

DRAWING

ELECTRICAL AS BUILT

DRAWN BY:

HONAAM CO.

INSPECTED BY: BEHROUZ ARMANI

WEBSITE

WWW.HONAAM.COM

MAIL

mail@honaam.com

PROJECT

MAAH NAAZ 4 RESIDENCE

LOCATION:

JAHAN SHAHR, ALBORZ

NASTARAN ST NO 101

DESCRIPTION

REV	DATE	NOTES
01	2024/07/21	---

DRAWING

HONAAM CO.

CHECKED BY

BEHROUZ ARMANI

NO.

H-236

REV.

01

SCALE

1:100

PAGE

E- 000

PAGE 1 of 21

List of Electrical Installation Drawings

Page no	Description
E- 000	List of Electrical Installation Drawings
E- 101	Basement Electrical Lighting Plan
E- 102	Ground Electrical Lighting Plan
E- 103	1~5th Floor Electrical Lighting Plan
E- 104	Roof Electrical Lighting Plan
E- 201	Basement Electrical Power Plan
E- 202	Ground Electrical Power Plan
E- 203	1~5th Floor Electrical Power Plan
E- 204	Roof Electrical Power Plan
E- 301	Basement Electrical Fire Alarm Plan
E- 302	Ground Electrical Fire Alarm Plan
E- 303	1~5th Floor Electrical Fire Alarm Plan
E- 304	Roof Electrical Fire Alarm Plan
E- 305	Alarm System Diagram
E- 401	Foundation Earthing Plan
E- 402	Ground Tel, ant, sat and net Socket
E- 403	1~5th Floor Tel, ant, sat and net Socket
E- 501	Riser Diagram
E- 502	Electrical Specifications
E- 503	Electrical Panels
E- 504	Electrical Panels

DRAWING

ELECTRICAL AS BUILT

DRAWN BY:

HONAAM CO.

INSPECTED BY: BEHROUZ ARMANI

WEBSITE

WWW.HONAAM.COM

MAIL

mail@honaam.com

PROJECT

MAAH NAAZ 4 RESIDENCE

LOCATION:

JAHAN SHAHR, ALBORZ

NASTARAN ST NO 101

DESCRIPTION

REV	DATE	NOTES
01	2024/07/21	---

DRAWING

HONAAM CO.

CHECKED BY

BEHROUZ ARMANI

NO.

H-236

REV.


01

SCALE

1:100

PAGE

E- 101

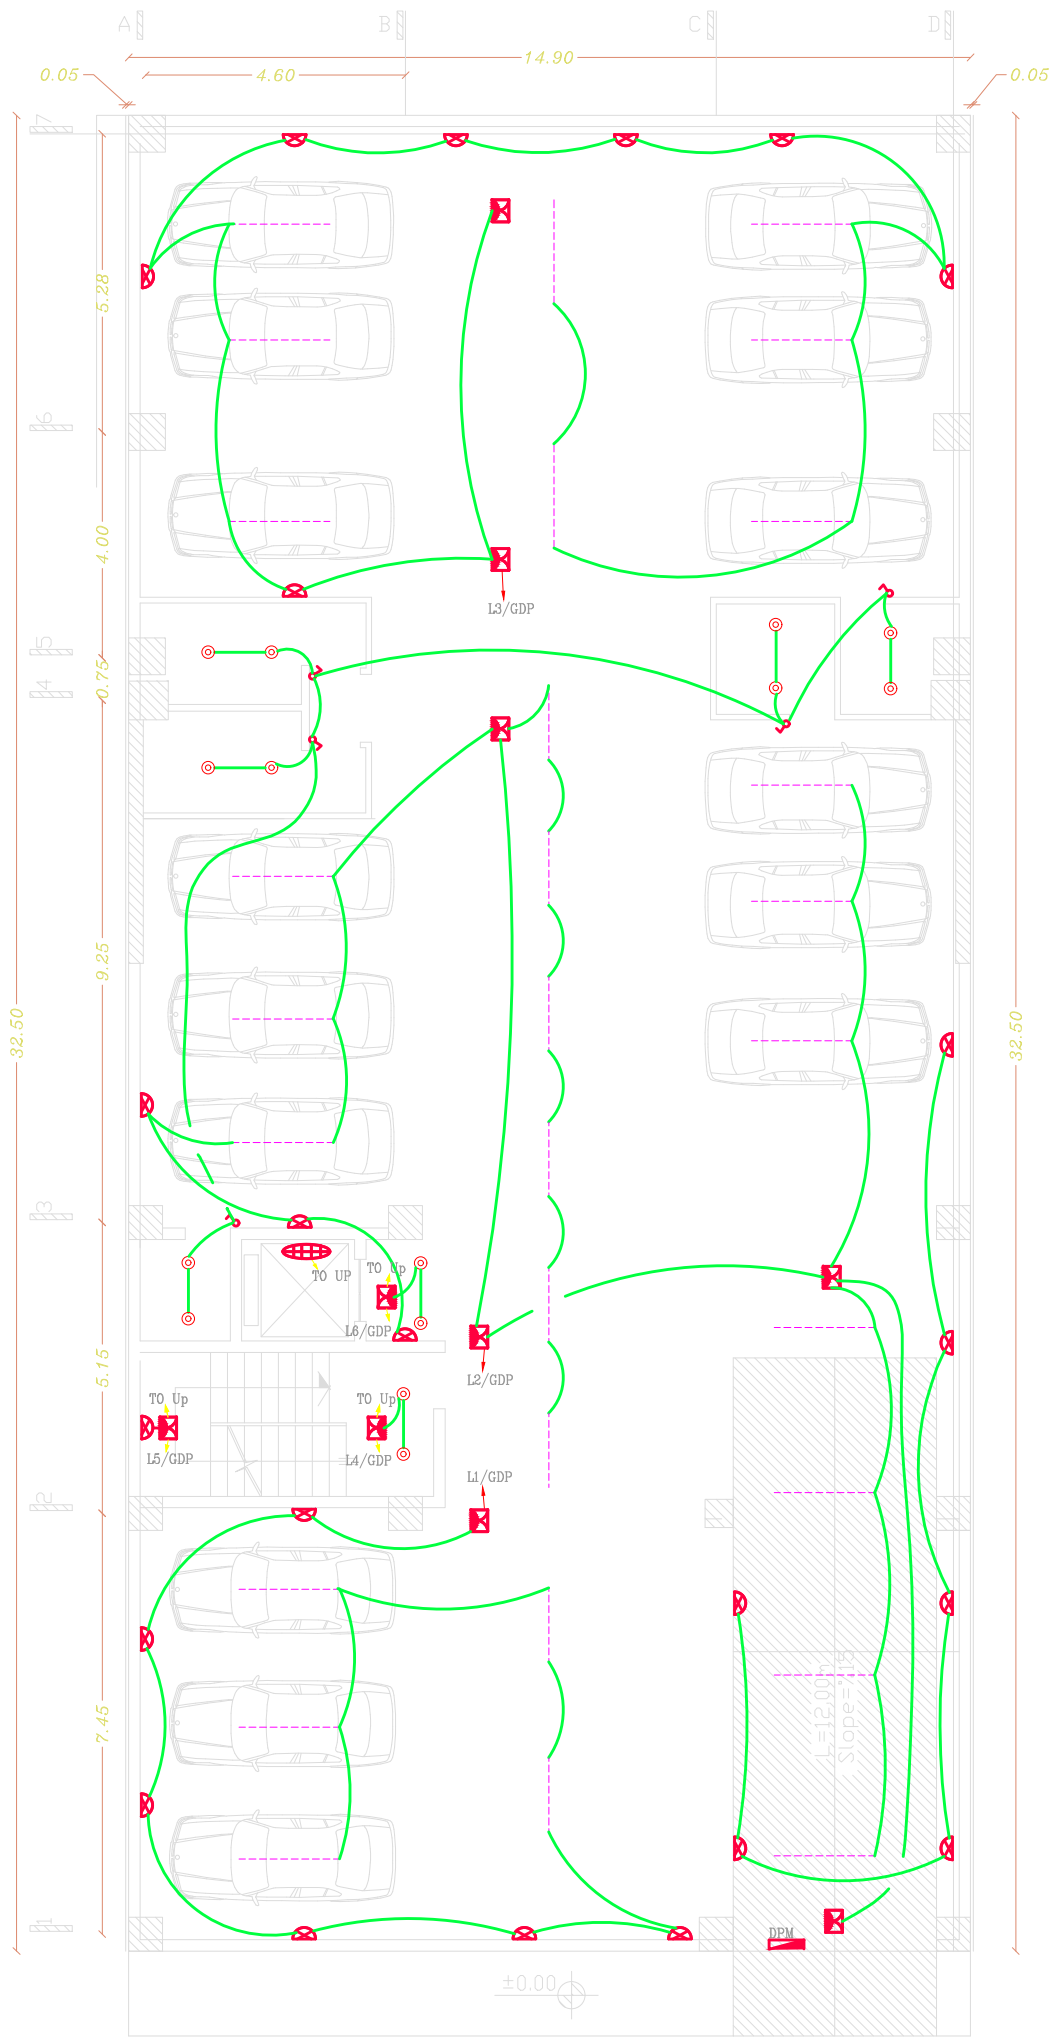

Electrical Lighting Plan

Sc 1:100

Basement

ELECTRICAL AS BUILT

INSPECTED BY: BEHROUZ ARMANI

WWW.HONAAM.COM

mail@honaam.com

MAAH NAAZ 4 RESIDENCE

LOCATION:

NASTARAN ST NO 101

DESCRIPTION

REV	DATE	NOTES
01	2024/07/21	---

HONAAM CO.


BEHROUZ ARMANI

H-236

01

1:100

E- 102

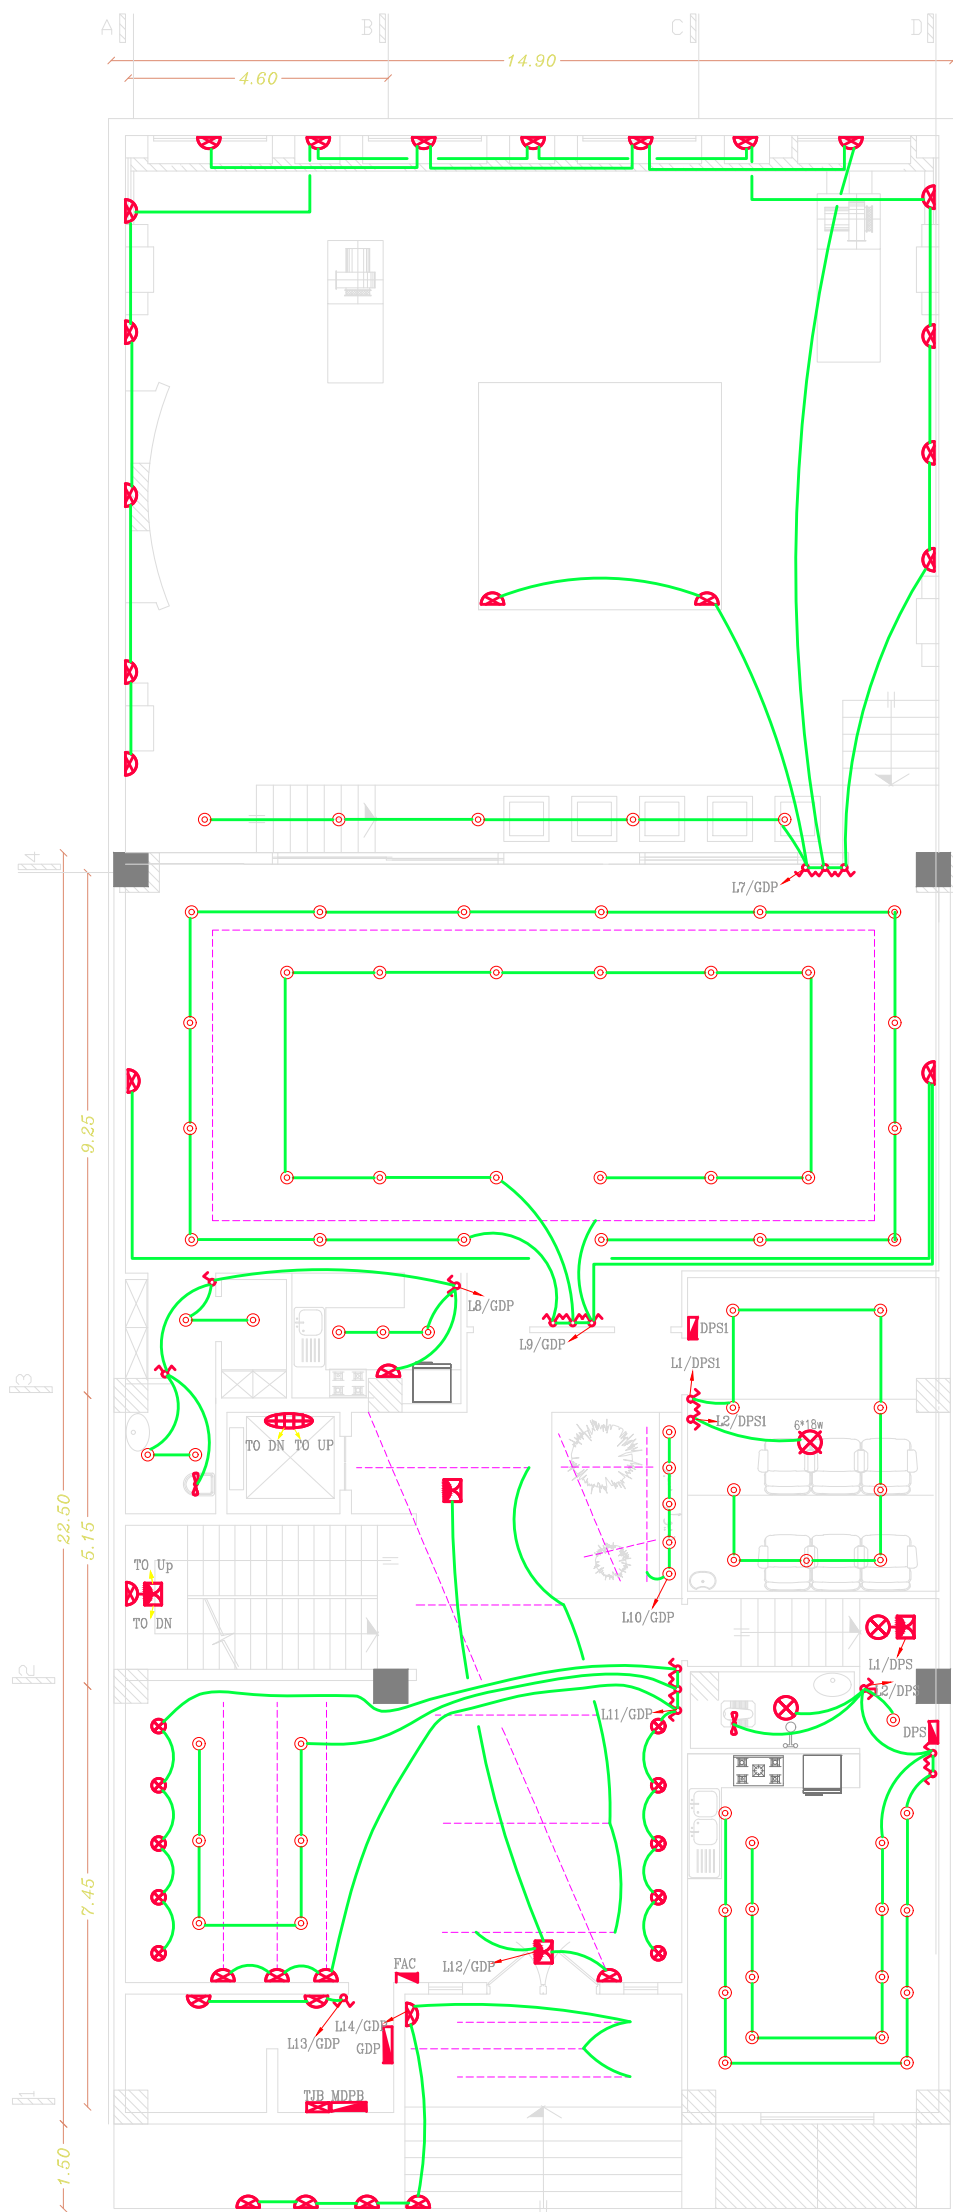

Sc 1:100

Ground

DRAWING

ELECTRICAL AS BUILT

DRAWN BY:

HONAAM CO.

INSPECTED BY: BEHROUZ ARMANI

WEBSITE

WWW.HONAAM.COM

MAIL

mail@honaam.com

PROJECT

MAAH NAAZ 4 RESIDENCE

LOCATION:

JAHAN SHAHR, ALBORZ

NASTARAN ST NO 101

DESCRIPTION

REV	DATE	NOTES
01	2024/07/21	---

DRAWING

HONAAM CO.

CHECKED BY

BEHROUZ ARMANI

NO.

H-236

REV.


01

SCALE

1:100

PAGE

E- 103

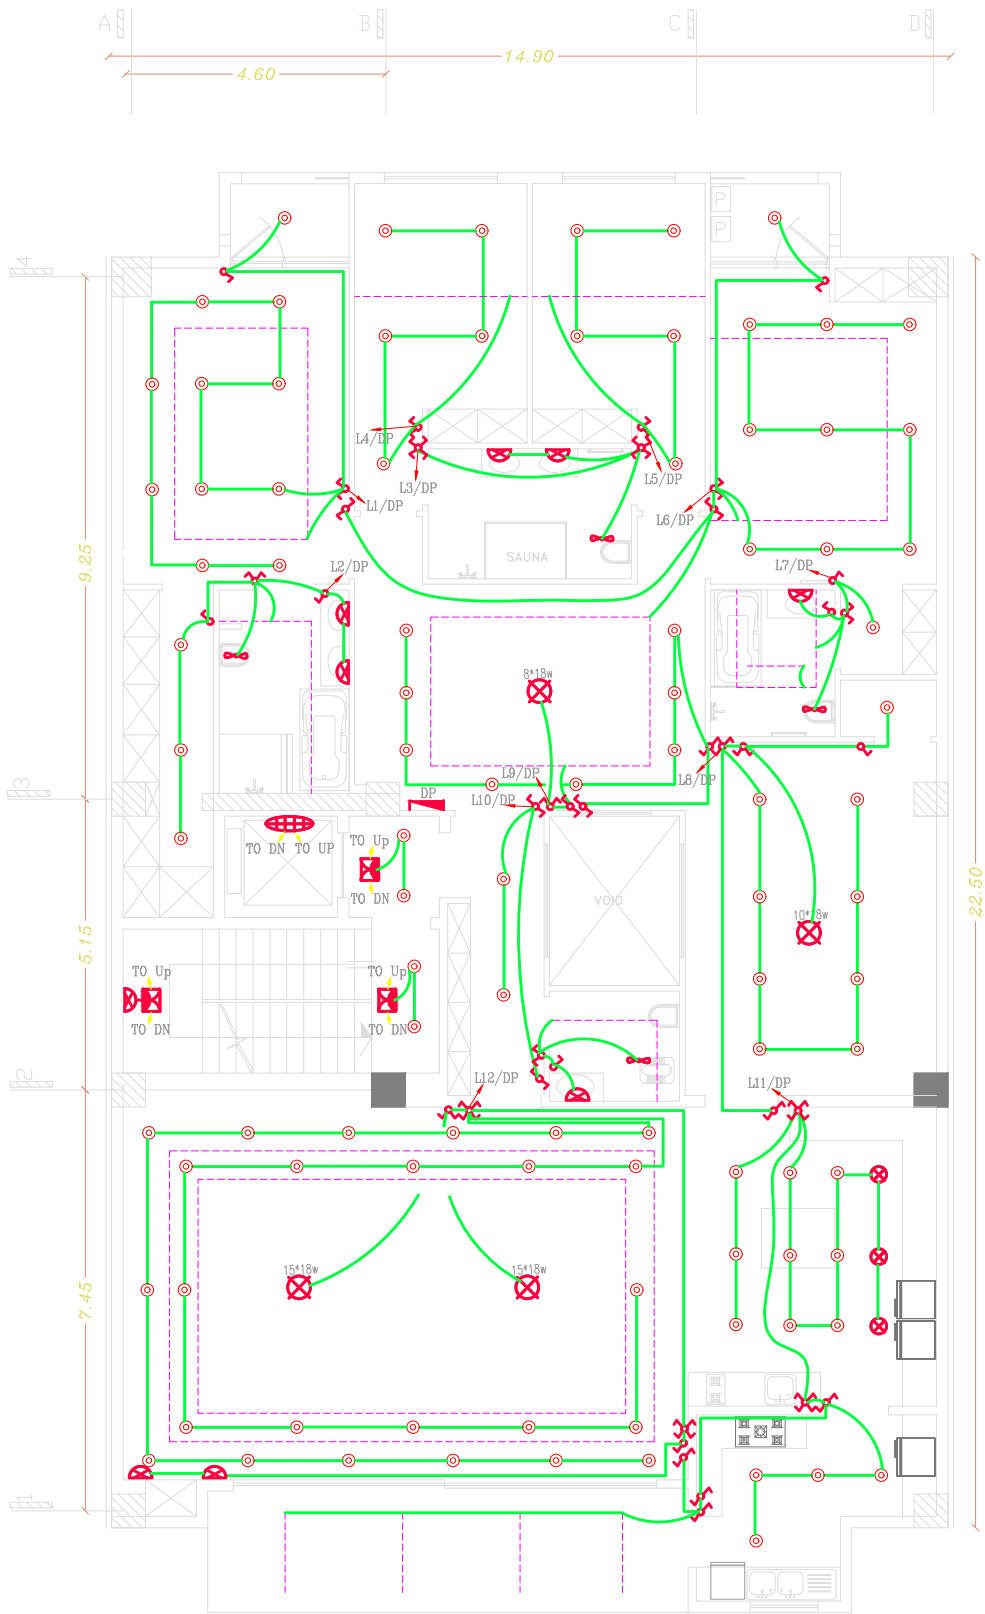

Electrical Lighting Plan

Sc 1:100

1~5th Floor

DRAWING

ELECTRICAL AS BUILT

DRAWN BY:

HONAAM CO.

INSPECTED BY: BEHROUZ ARMANI

WEBSITE

WWW.HONAAM.COM

MAIL

mail@honaam.com

PROJECT

MAAH NAAZ 4 RESIDENCE

LOCATION:

JAHAN SHAHR, ALBORZ

NASTARAN ST NO 101

DESCRIPTION

REV	DATE	NOTES
01	2024/07/21	---

DRAWING

HONAAM CO.

CHECKED BY

BEHROUZ ARMANI

NO.

H-236

REV.


01

SCALE

1:100

PAGE

E- 201

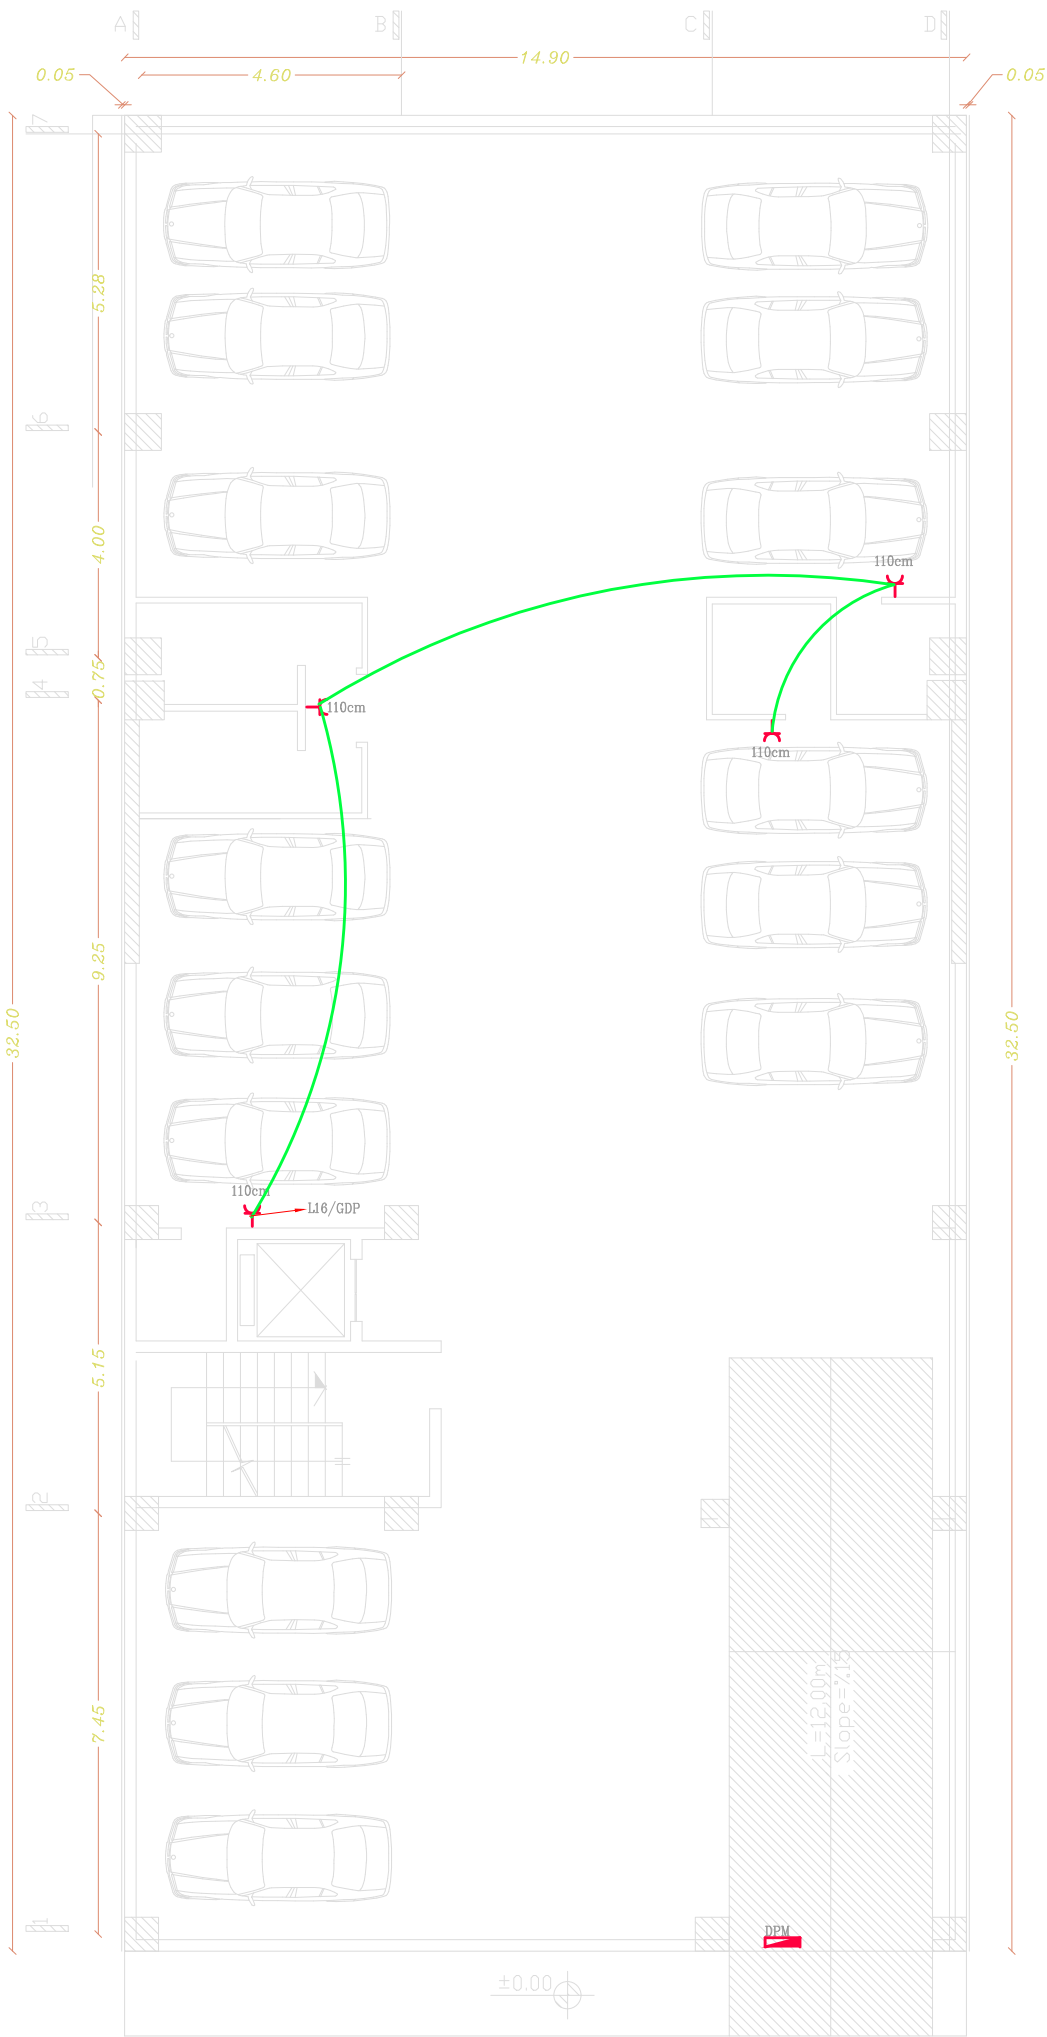

Electrical Power Plan

Sc 1:100

Basement

ELECTRICAL AS BUILT

DRAWN BY:

HONAAM CO.

INSPECTED BY: BEHROUZ ARMANI

WWW.HONAAM.COM

mail@honaam.com

MAAH NAAZ 4 RESIDENCE

LOCATION:

JAHAN SHAHR, ALBORZ

NASTARAN ST NO 101

DESCRIPTION

REV	DATE	NOTES
01	2024/07/21	---

HONAAM CO.


BEHROUZ ARMANI

H-236

01

1:100

E- 202

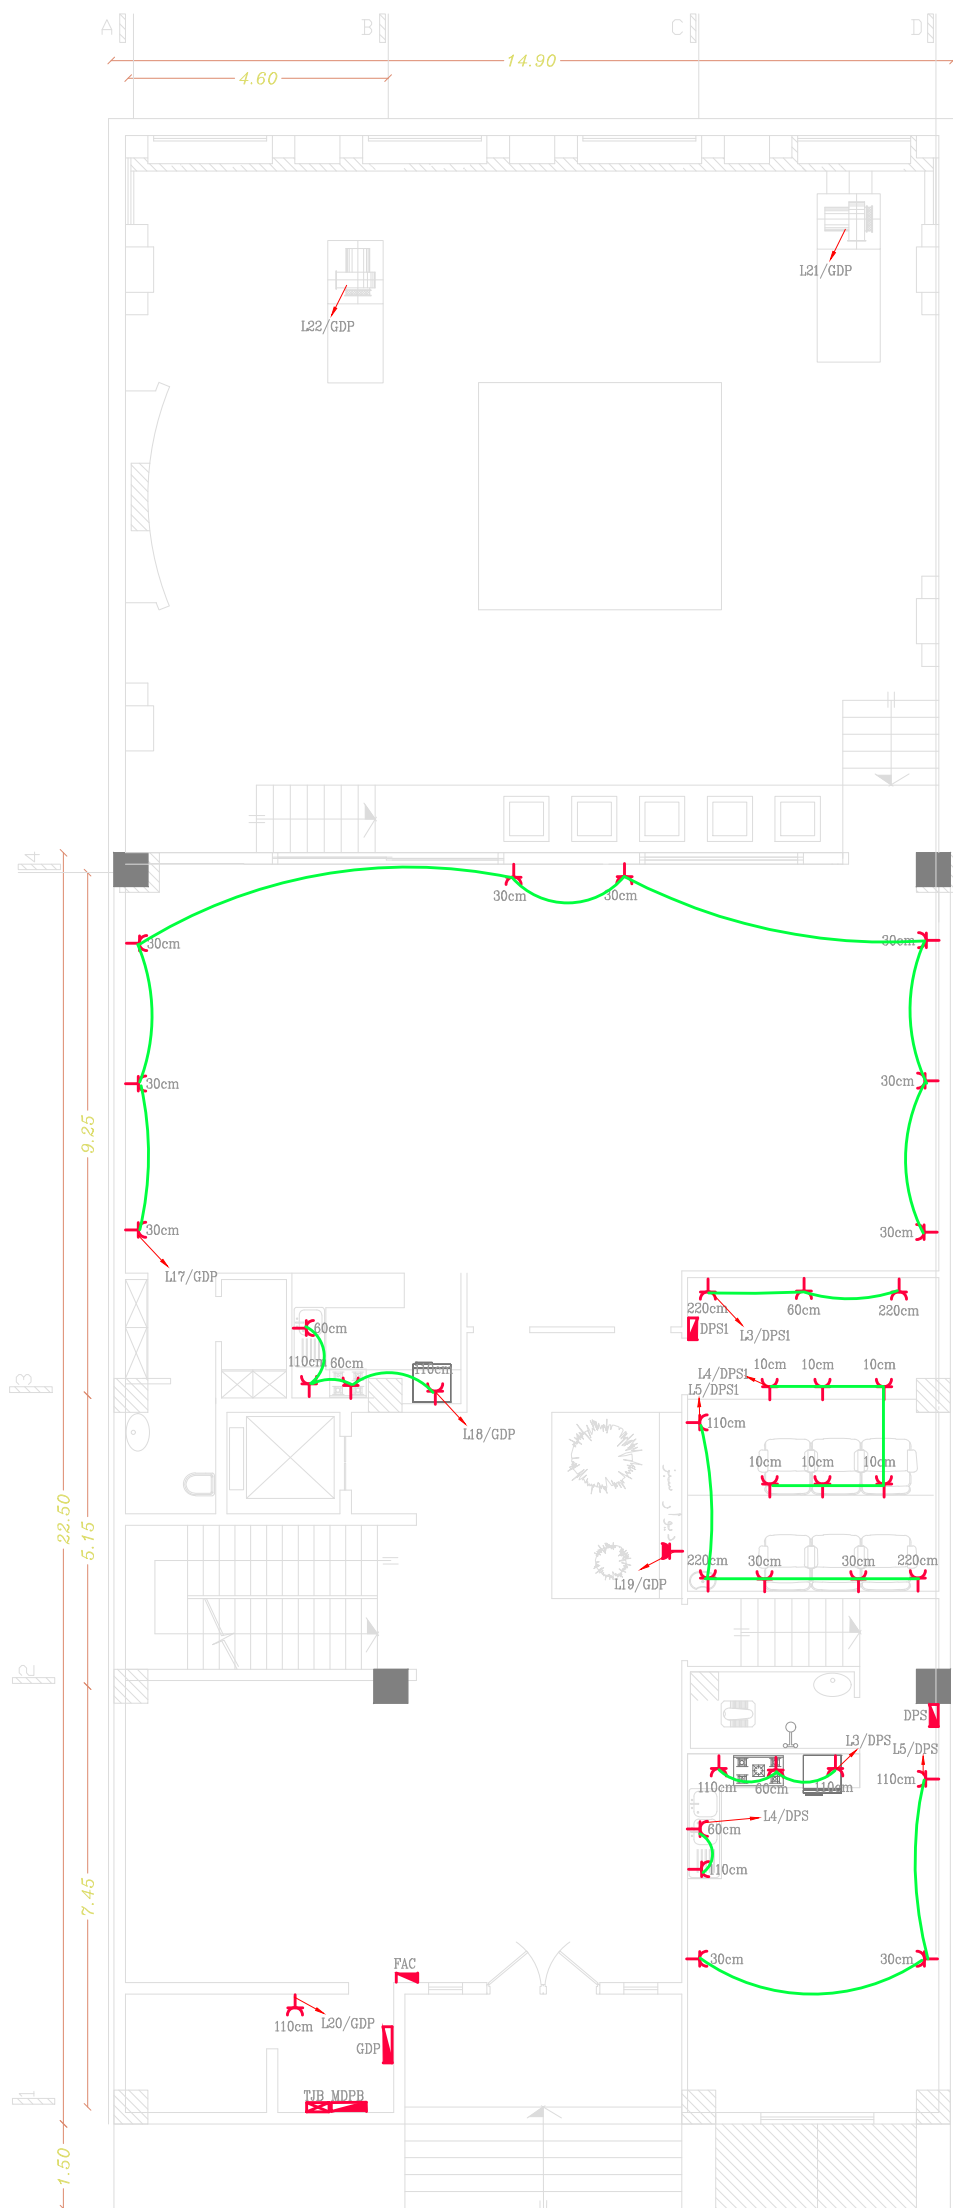

Electrical Lighting Plan

Sc 1:100

Ground

DRAWING

ELECTRICAL AS BUILT

DRAWN BY:

HONAAM CO.

INSPECTED BY: BEHROUZ ARMANI

WEBSITE

WWW.HONAAM.COM

MAIL

mail@honaam.com

PROJECT

MAAH NAAZ 4 RESIDENCE

LOCATION:

JAHAN SHAHR, ALBORZ

NASTARAN ST NO 101

DESCRIPTION

REV	DATE	NOTES
01	2024/07/21	---

DRAWING

HONAAM CO.

CHECKED BY

BEHROUZ ARMANI

NO.

H-236

REV.


01

SCALE

1:100

PAGE

E- 203

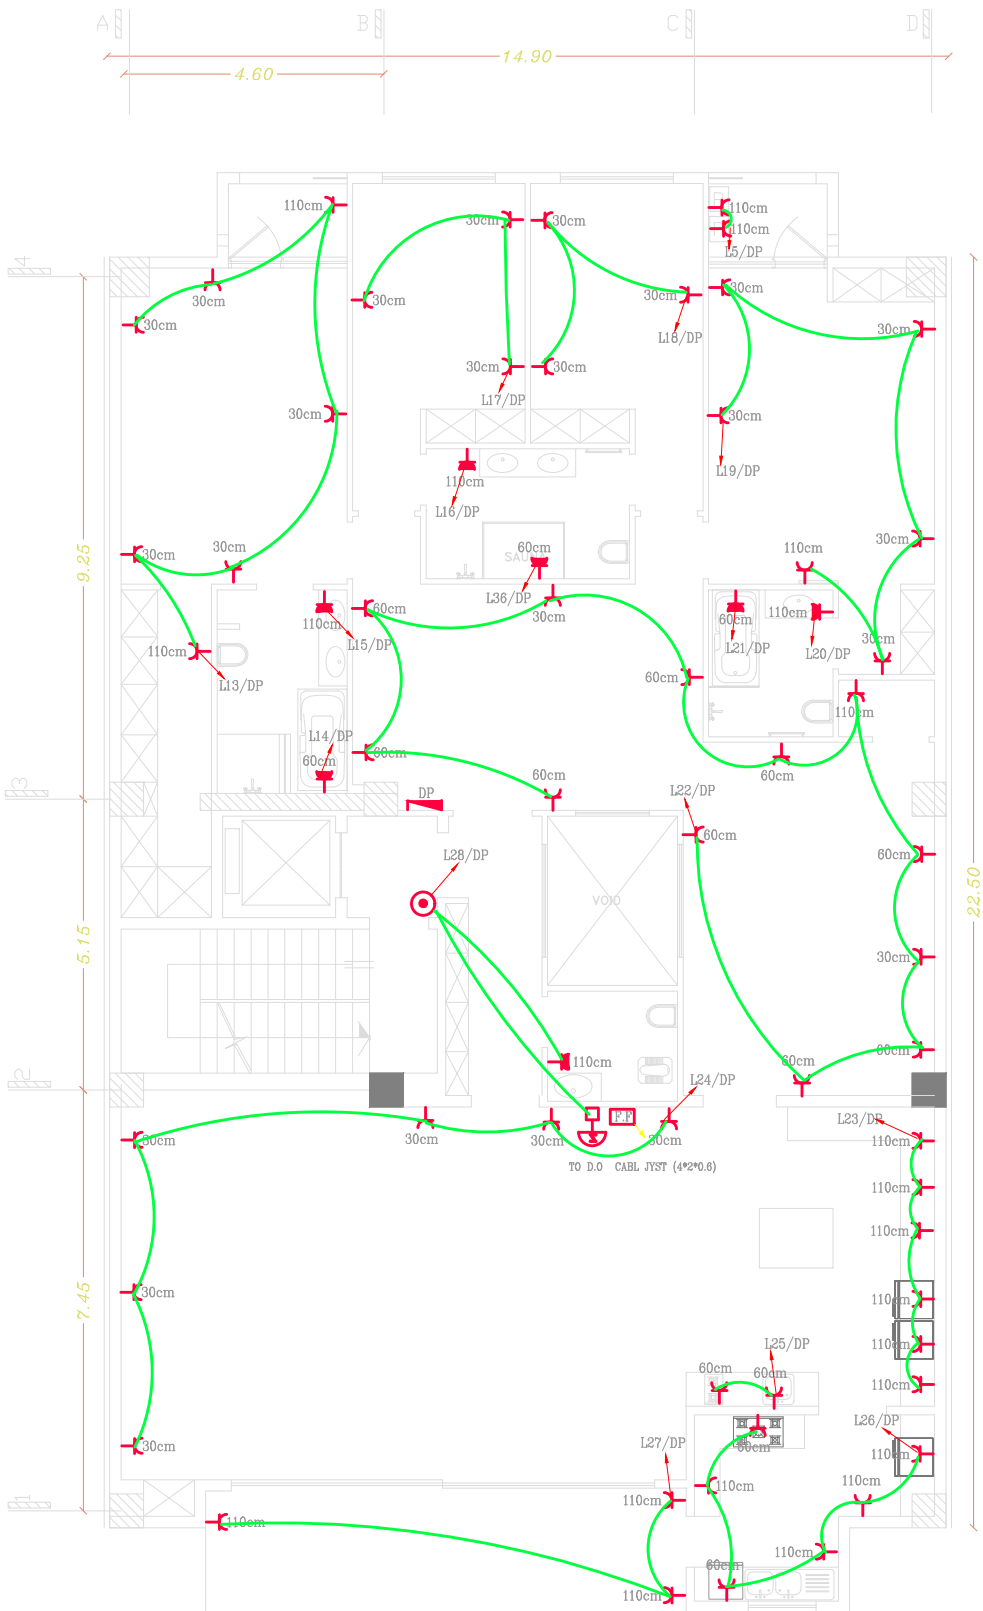

Electrical Lighting Plan

Sc 1:100

1~5th Floor

DRAWING

ELECTRICAL AS BUILT

DRAWN BY:

HONAAM CO.

INSPECTED BY: BEHROUZ ARMANI

WEBSITE

WWW.HONAAM.COM

MAIL

mail@honaam.com

PROJECT

MAAH NAAZ 4 RESIDENCE

LOCATION:

JAHAN SHAHR, ALBORZ

NASTARAN ST NO 101

DESCRIPTION

REV	DATE	NOTES
01	2024/07/21	---

DRAWING

HONAAM CO.

CHECKED BY

BEHROUZ ARMANI

NO.

H-236

REV.


01

SCALE

1:100

PAGE

E- 301

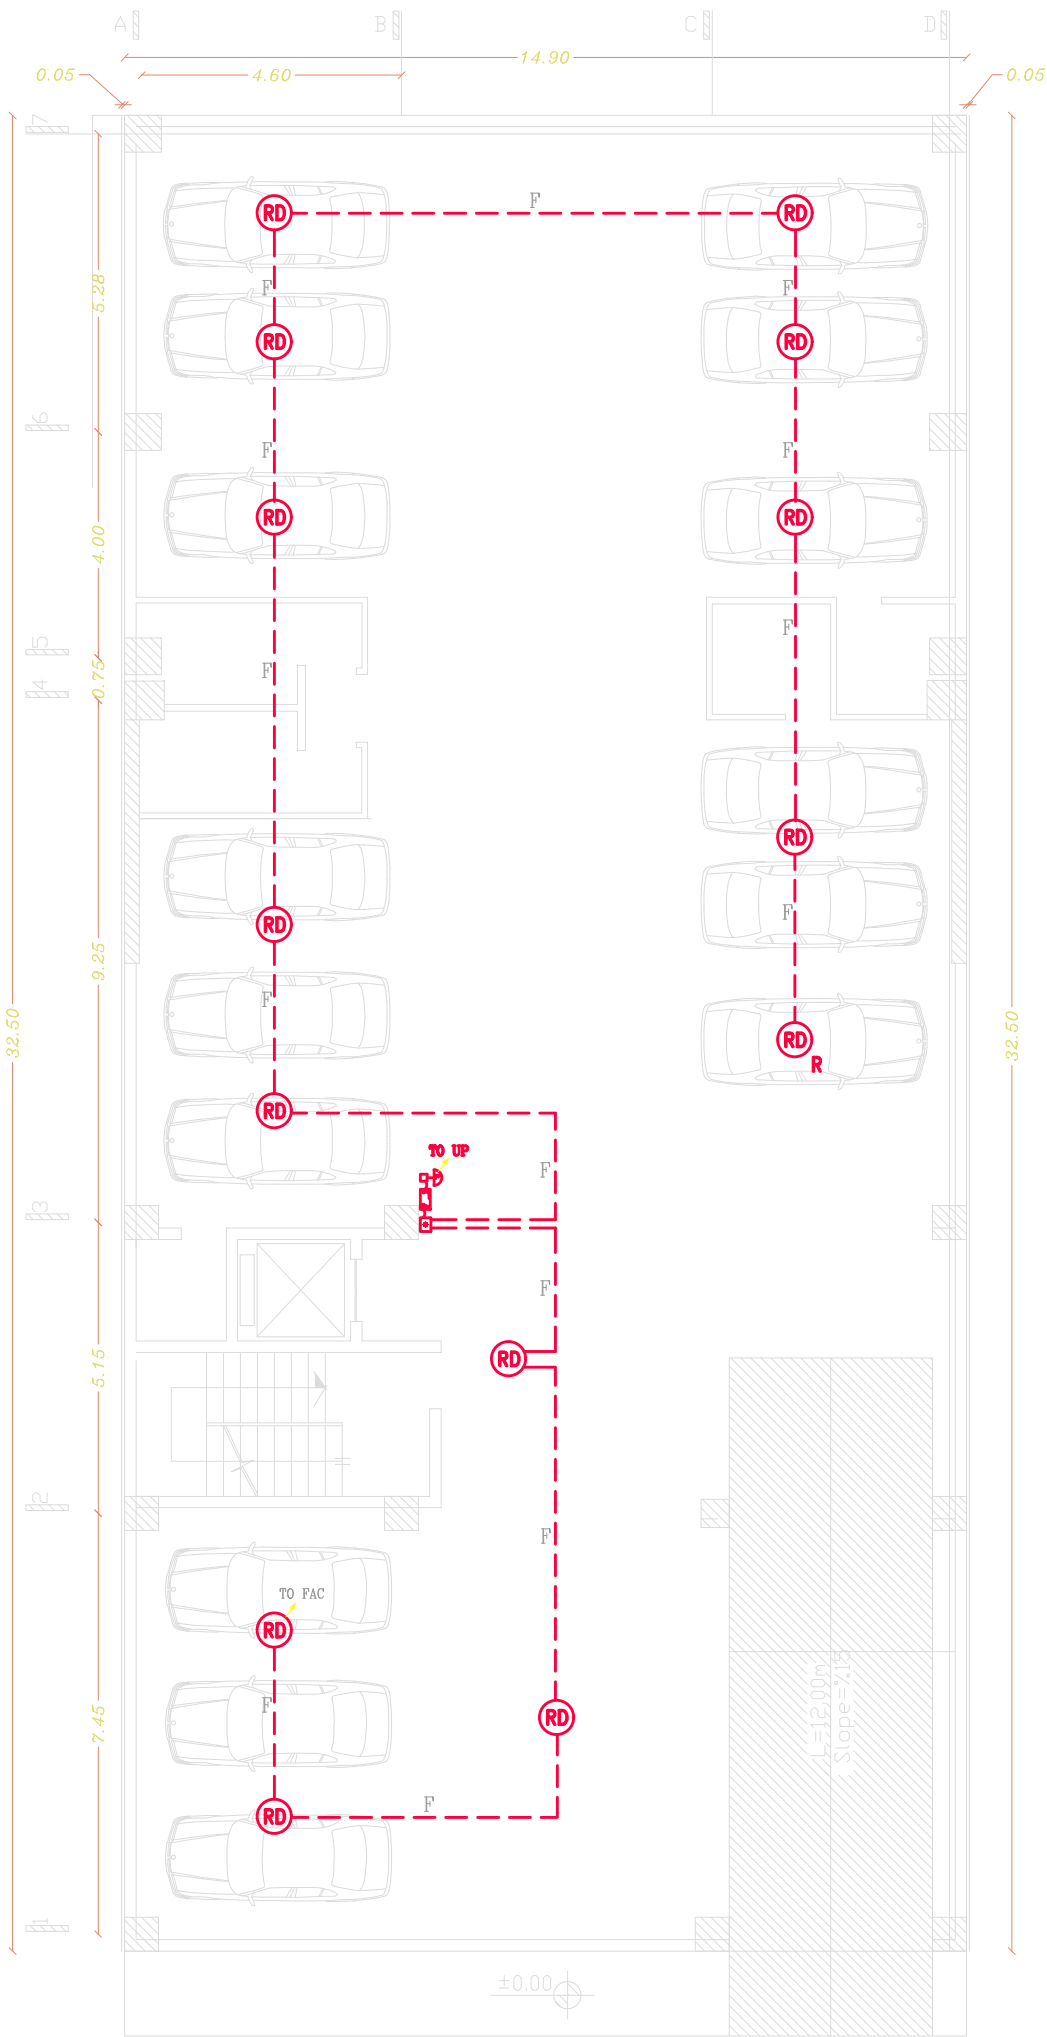

Electrical Fire Alarm Plan

Sc 1:100

Basement

DRAWING

ELECTRICAL AS BUILT

DRAWN BY:

HONAAM CO.

INSPECTED BY: BEHROUZ ARMANI

WEBSITE

WWW.HONAAM.COM

MAIL

mail@honaam.com

PROJECT

MAAH NAAZ 4 RESIDENCE

LOCATION:

JAHAN SHAHR, ALBORZ

NASTARAN ST NO 101

DESCRIPTION

REV	DATE	NOTES
01	2024/07/21	---

DRAWING

HONAAM CO.

CHECKED BY

BEHROUZ ARMANI

NO.

H-236

REV.


01

SCALE

1:100

PAGE

E- 302

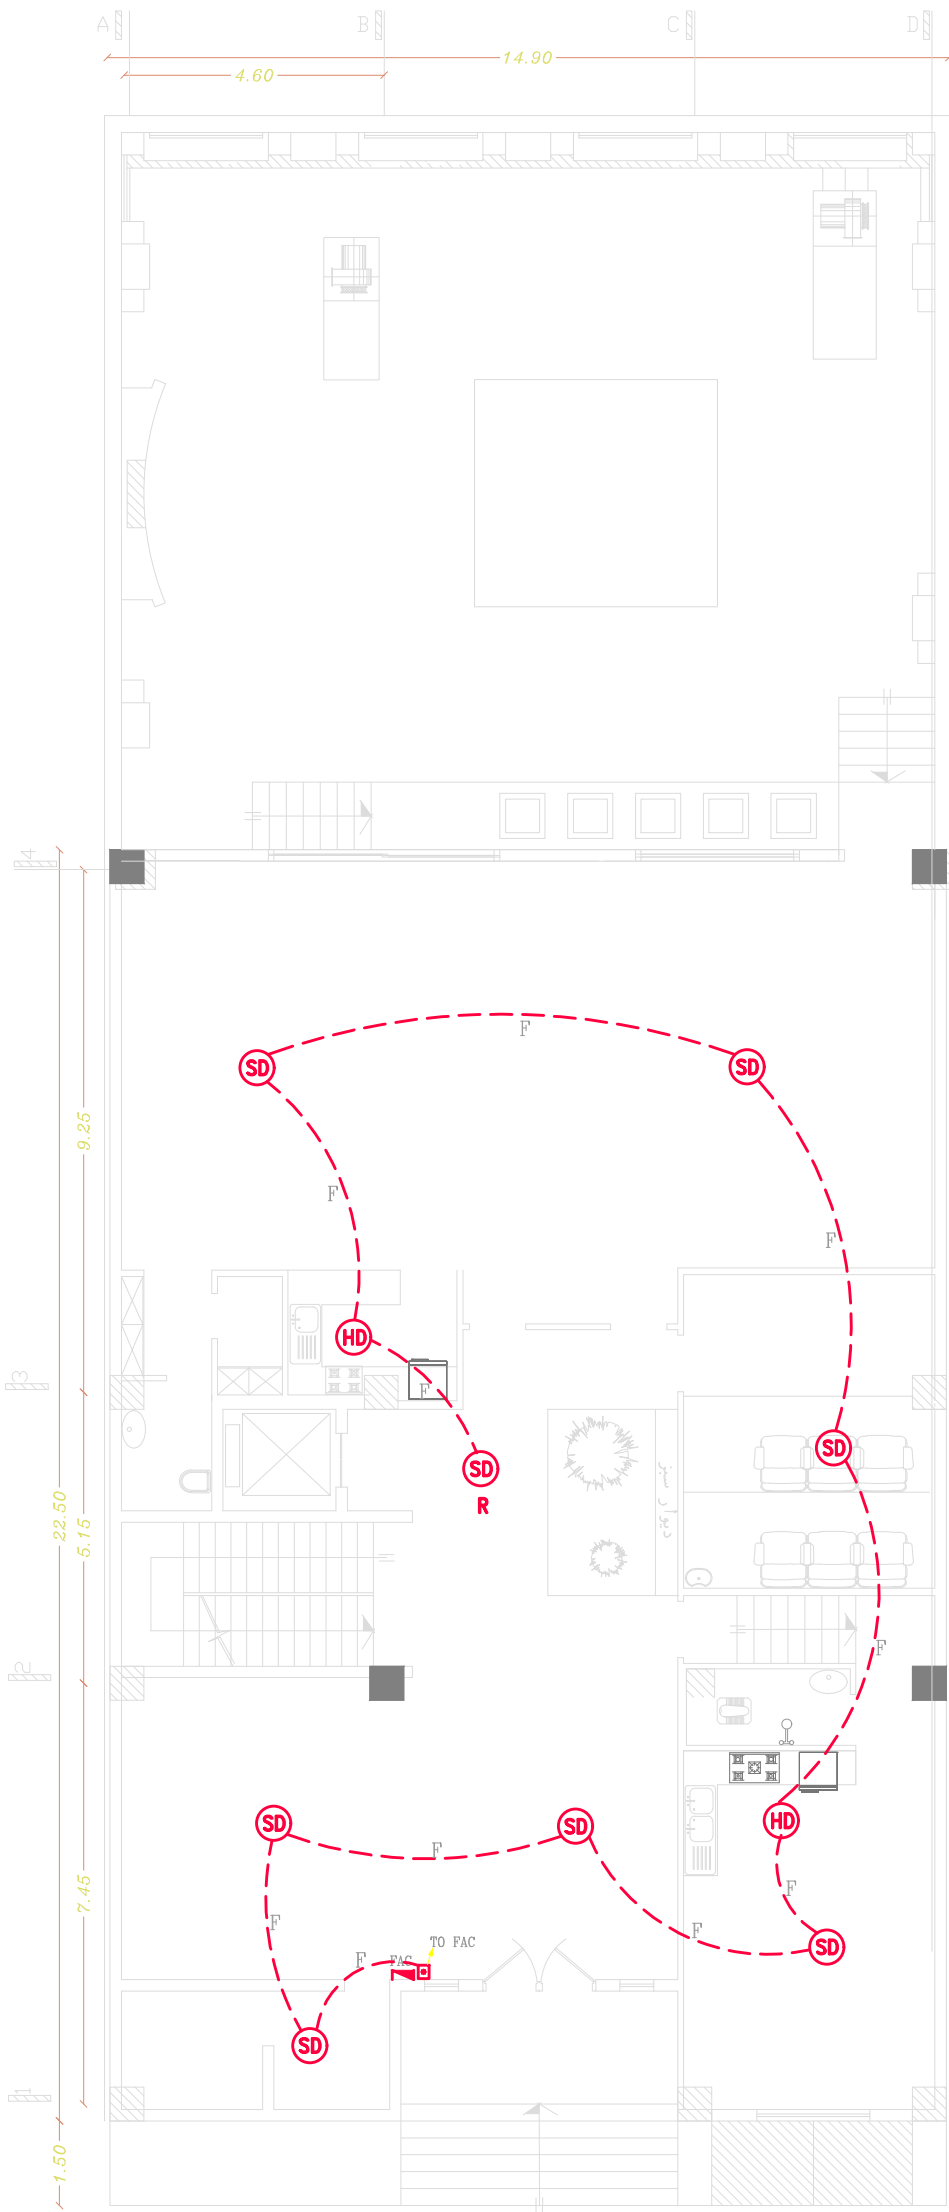

Electrical Fire Alarm Plan

Sc 1:100

Ground

DRAWING

ELECTRICAL AS BUILT

DRAWN BY:

HONAAM CO.

INSPECTED BY: BEHROUZ ARMANI

WEBSITE

WWW.HONAAM.COM

MAIL

mail@honaam.com

PROJECT

MAAH NAAZ 4 RESIDENCE

LOCATION:

JAHAN SHAHR, ALBORZ

NASTARAN ST NO 101

DESCRIPTION

REV	DATE	NOTES
01	2024/07/21	---

DRAWING

HONAAM CO.

CHECKED BY

BEHROUZ ARMANI

NO.

H-236

REV.


01

SCALE

1:100

PAGE

E- 303

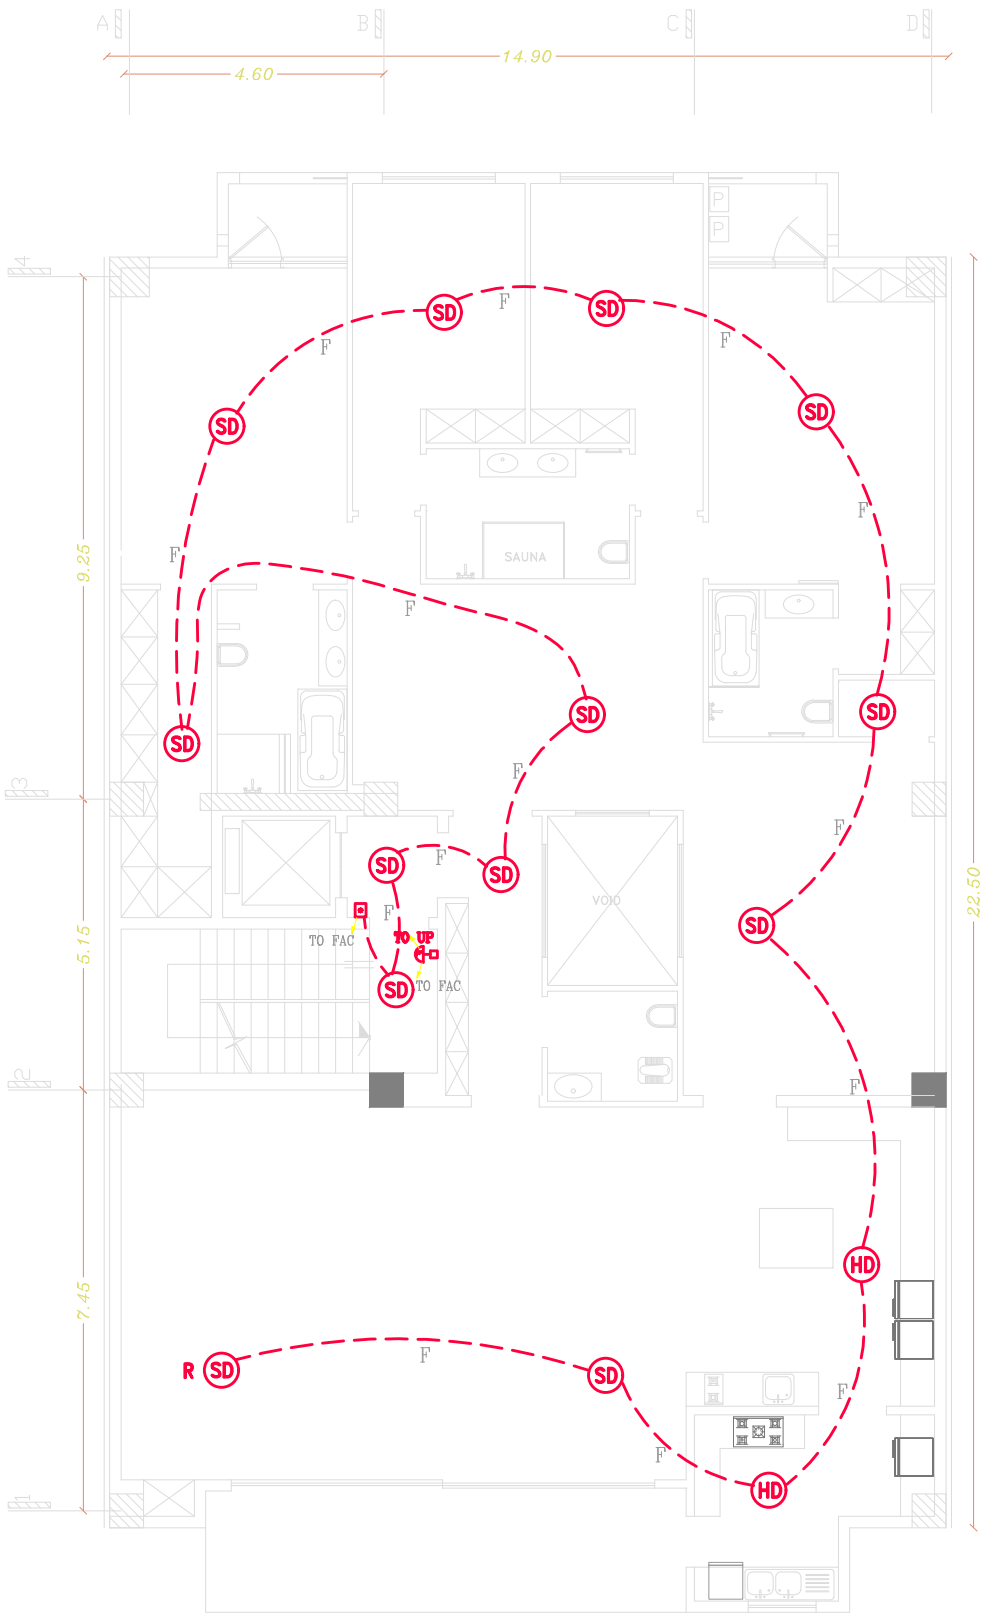

DRAWING

ELECTRICAL AS BUILT

DRAWN BY:

HONAAM CO.

INSPECTED BY: BEHROUZ ARMANI

WEBSITE

WWW.HONAAM.COM

MAIL

mail@honaam.com

PROJECT

MAAH NAAZ 4 RESIDENCE

LOCATION:

JAHAN SHAHR, ALBORZ

NASTARAN ST NO 101

DESCRIPTION

REV	DATE	NOTES
01	2024/07/21	--

DRAWING

HONAAM CO.

CHECKED BY

BEHROUZ ARMANI

NO.

H-236

REV.


01

SCALE

1:100

PAGE

E- 305

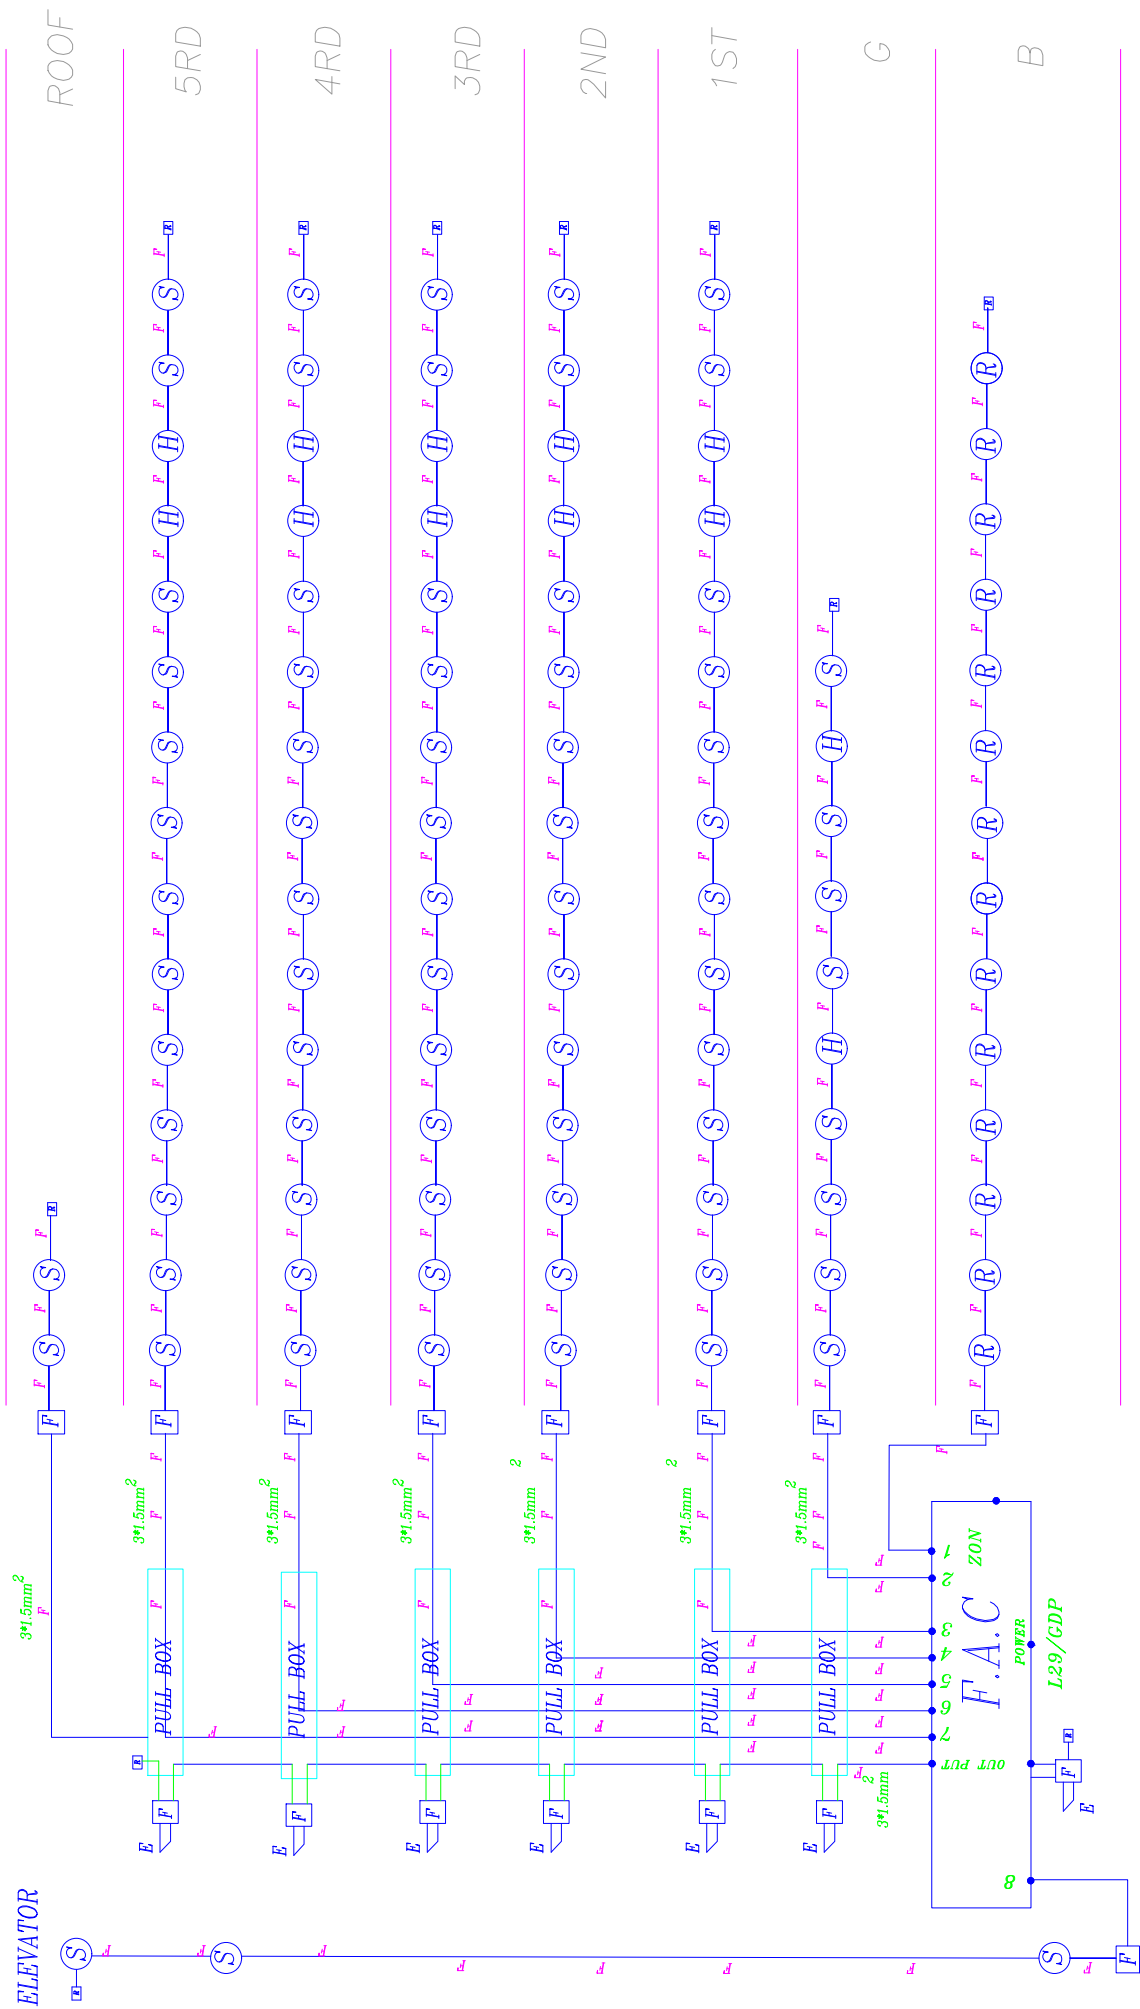

Alarm System Diagram

Sc 1:100

F.A.C

DRAWING

ELECTRICAL AS BUILT

DRAWN BY:

HONAAM CO.

INSPECTED BY: BEHROUZ ARMANI

WEBSITE

WWW.HONAAM.COM

MAIL

mail@honaam.com

PROJECT

MAAH NAAZ 4 RESIDENCE

LOCATION:

JAHAN SHAHR, ALBORZ

NASTARAN ST NO 101

DESCRIPTION

REV	DATE	NOTES
01	2024/07/21	---

DRAWING

HONAAM CO.

CHECKED BY

BEHROUZ ARMANI

NO.

H-236

REV.


01

SCALE

1:100

PAGE

E- 401

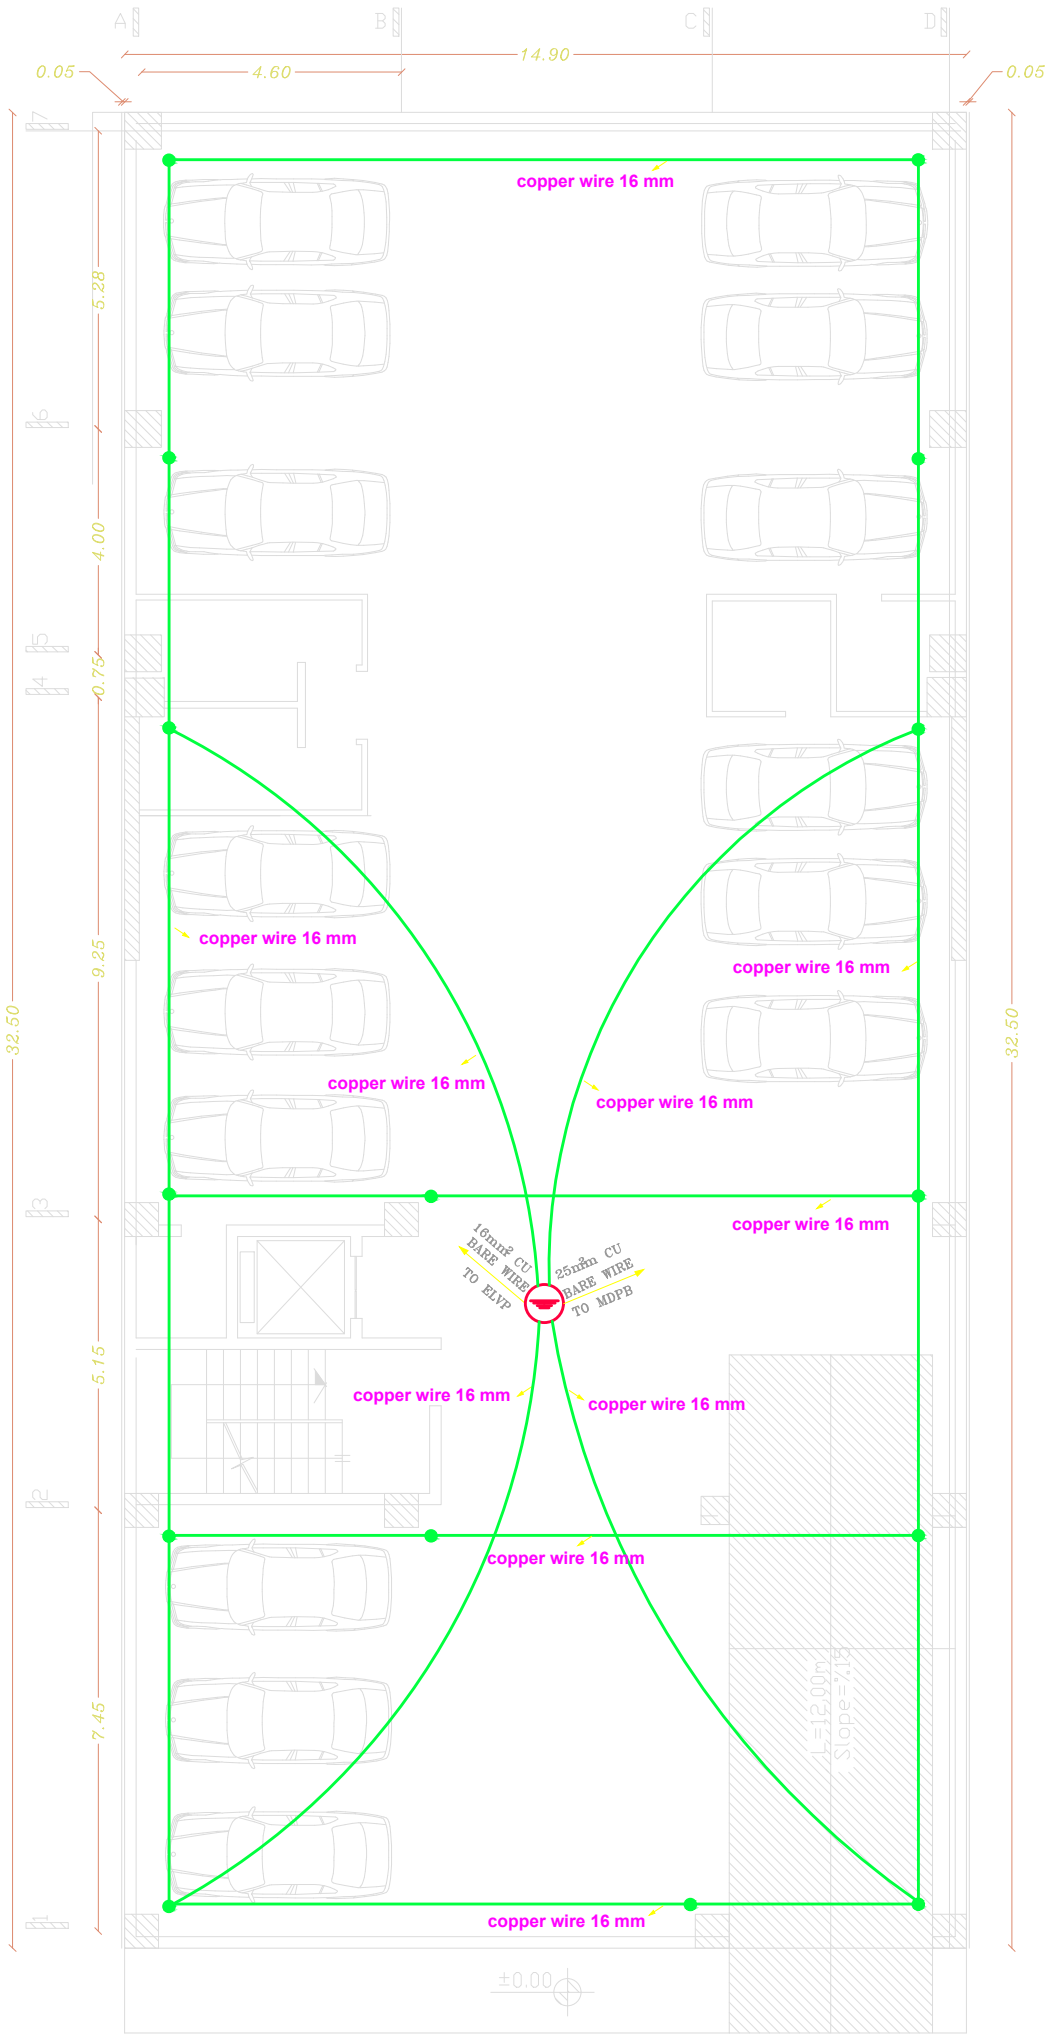

Foundation Earthing Plan

Sc 1:100

Basement

DRAWING

ELECTRICAL AS BUILT

DRAWN BY:

HONAAM CO.

INSPECTED BY: BEHROUZ ARMANI

WEBSITE

WWW.HONAAM.COM

MAIL

mail@honaam.com

PROJECT

MAAH NAAZ 4 RESIDENCE

LOCATION:

JAHAN SHAHR, ALBORZ

NASTARAN ST NO 101

DESCRIPTION

REV	DATE	NOTES
01	2024/07/21	---

DRAWING

HONAAM CO.

CHECKED BY

BEHROUZ ARMANI

NO.

H-236

REV.


01

SCALE

1:100

PAGE

E- 403

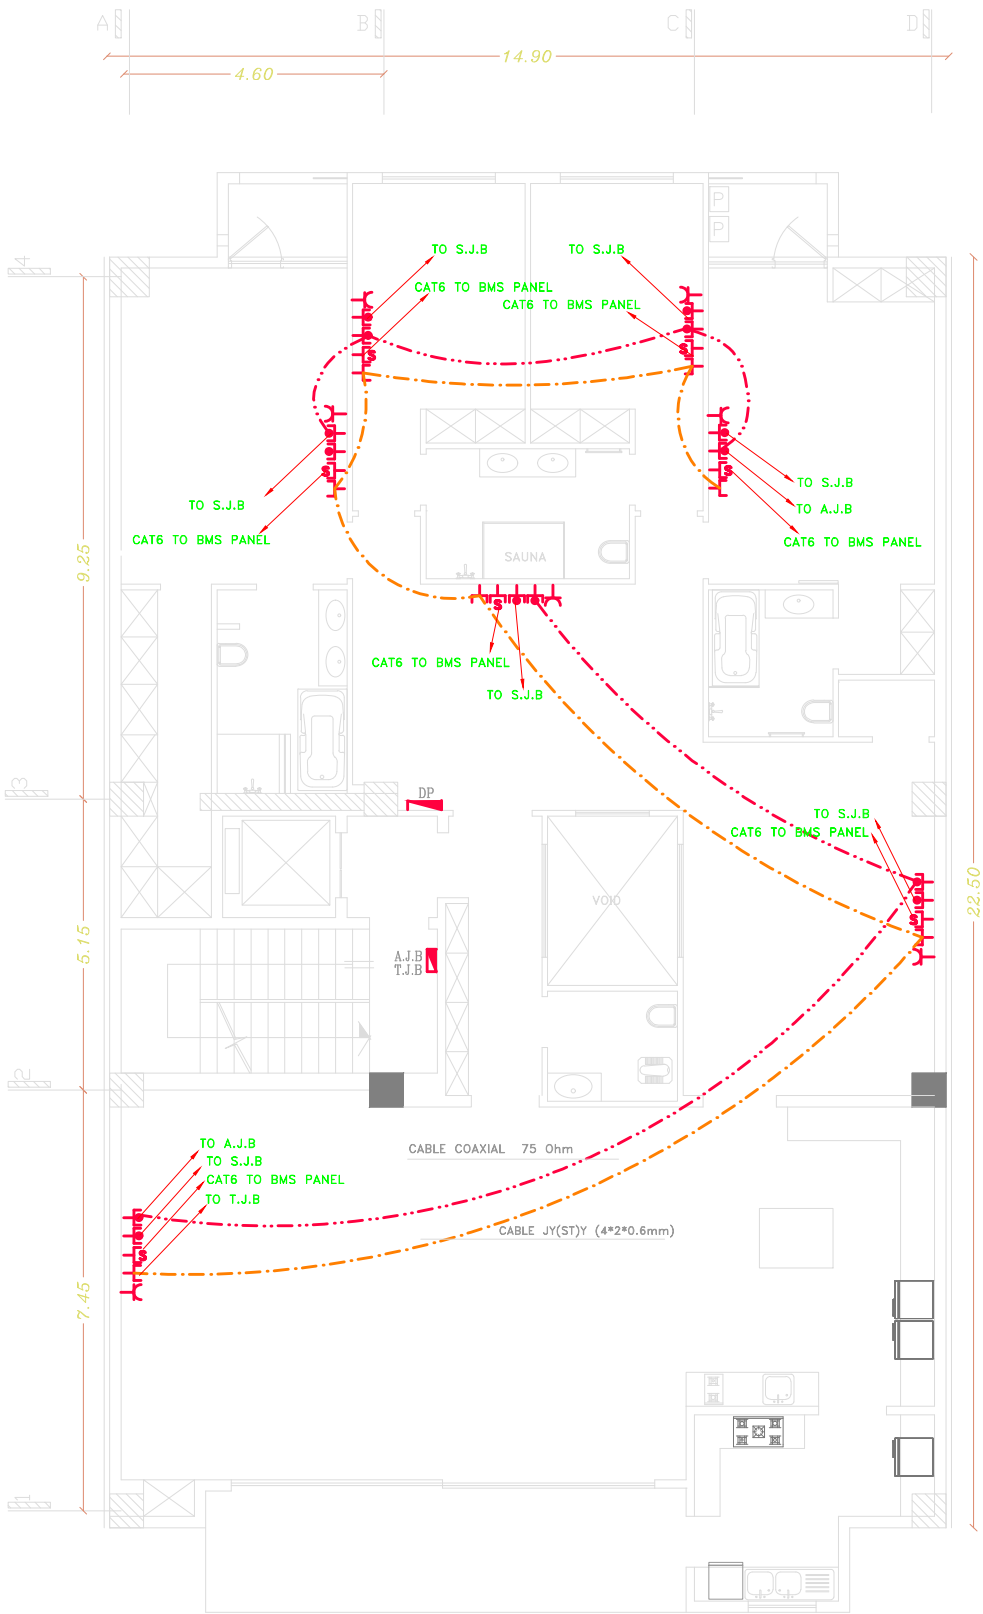

Tel, ant, sat and net Socket

Sc 1:100

1~5th Floor

DRAWING

ELECTRICAL AS BUILT

DRAWN BY:

HONAAM CO.

INSPECTED BY: BEHROUZ ARMANI

WEBSITE

WWW.HONAAM.COM

MAIL

mail@honaam.com

PROJECT

MAAH NAAZ 4 RESIDENCE

LOCATION:

JAHAN SHAHR, ALBORZ

NASTARAN ST NO 101

DESCRIPTION

REV	DATE	NOTES
01	2024/07/21	---

DRAWING

HONAAM CO.

CHECKED BY

BEHROUZ ARMANI

NO.

H-236

REV.


01

SCALE


1:100

PAGE


E- 501

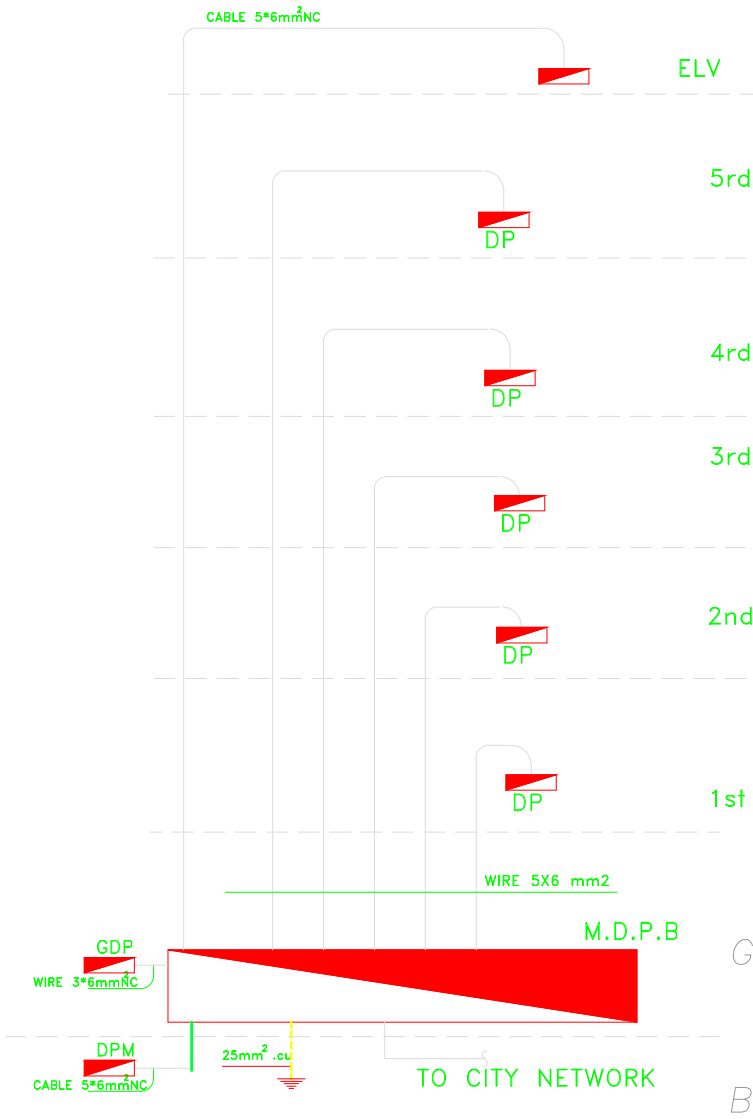


POWER DISTRIBUTION
RISER DIAGRAM

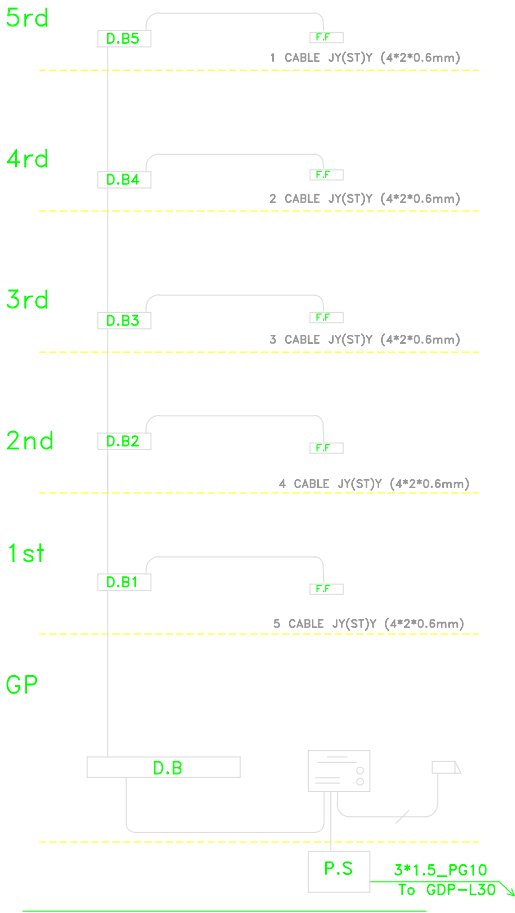

D.O RISER DIAGRAM

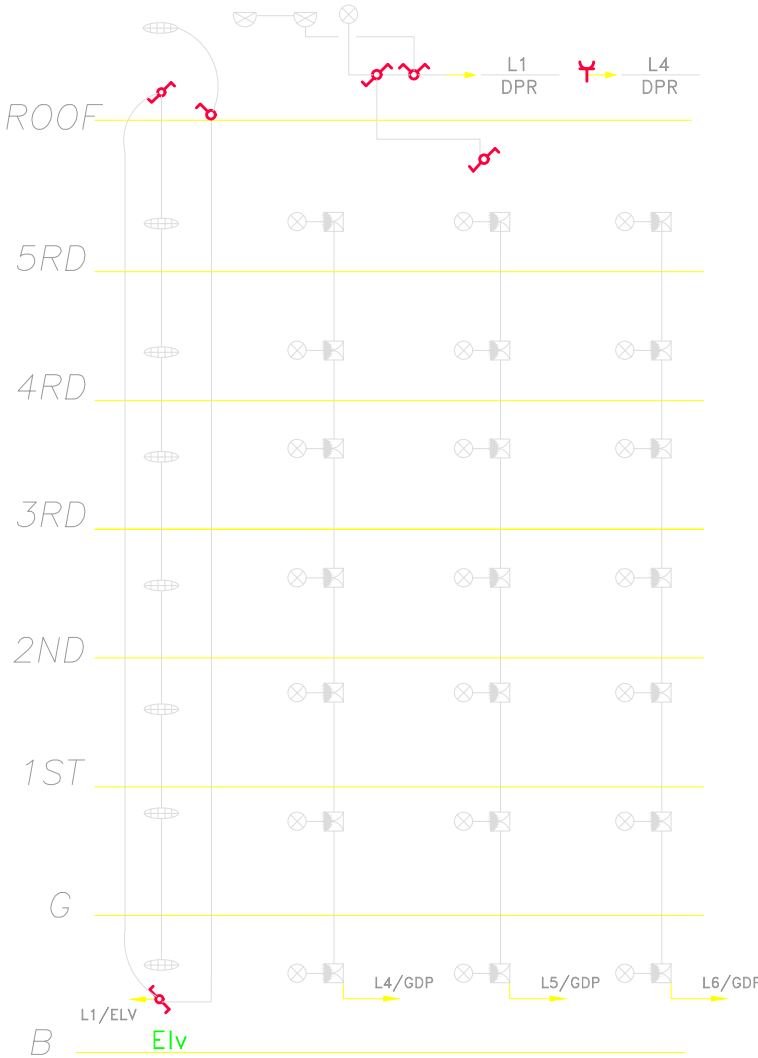

STAIR LIGHTING
RISER DIAGRAM

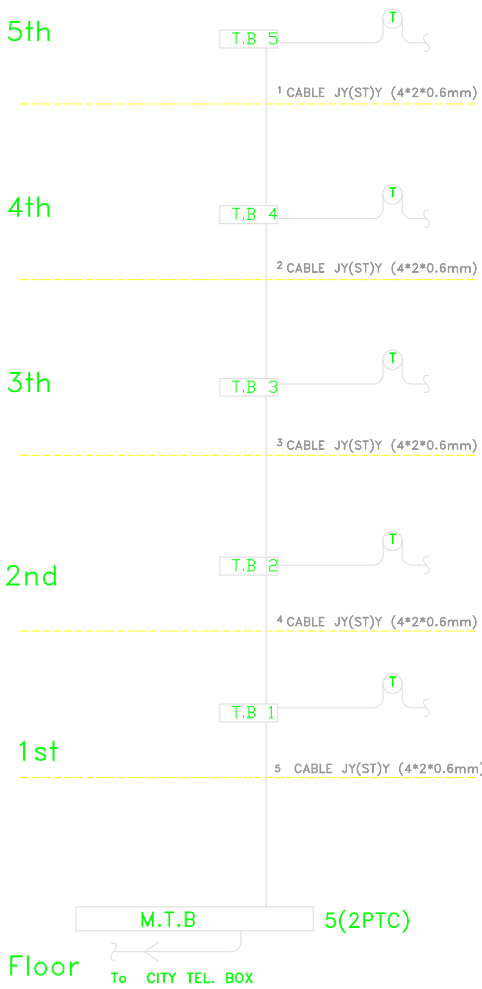

TEL RISER DIAGRAM

DRAWING

ELECTRICAL AS BUILT

DRAWN BY:

HONAAM CO.

INSPECTED BY: BEHROUZ ARMANI

WEBSITE

WWW.HONAAM.COM

MAIL

mail@honaam.com

PROJECT

MAAH NAAZ 4 RESIDENCE

LOCATION:

JAHAN SHAHR, ALBORZ

NASTARAN ST NO 101

DESCRIPTION

REV	DATE	NOTES
01	2024/07/21	---

DRAWING

HONAAM CO.

CHECKED BY

BEHROUZ ARMANI

NO.

H-236

REV.


01

SCALE

1:100



PAGE

E- 503

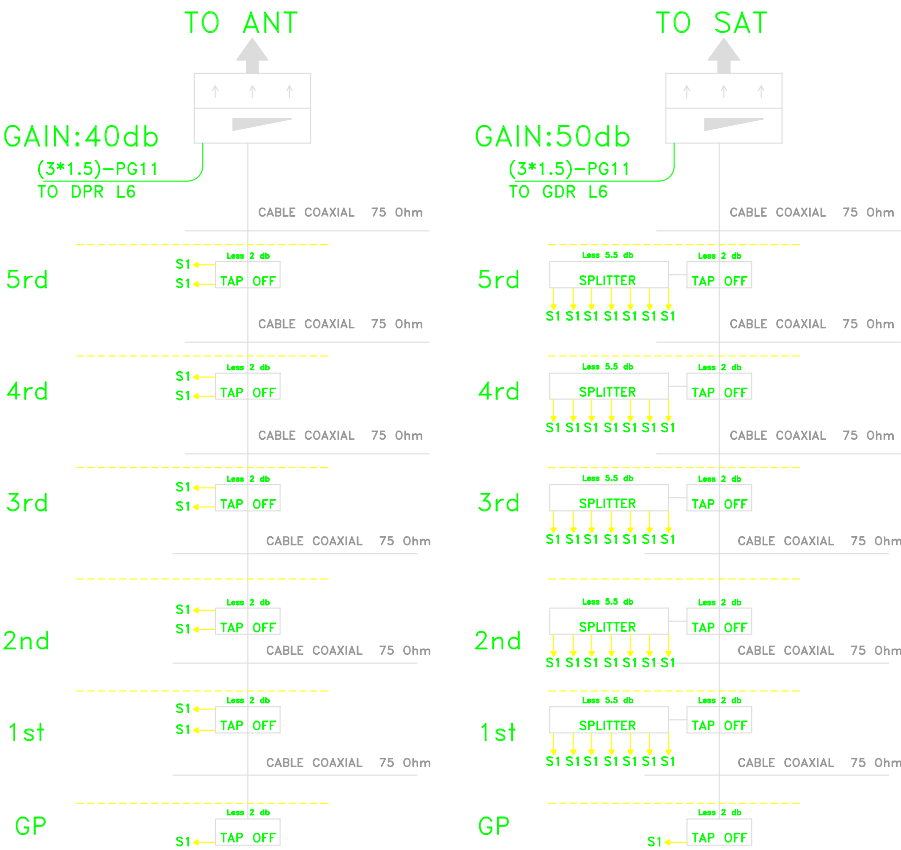


TV Ant RISER DIAGRAM


Sat.L Ant RISER DIAGRAM

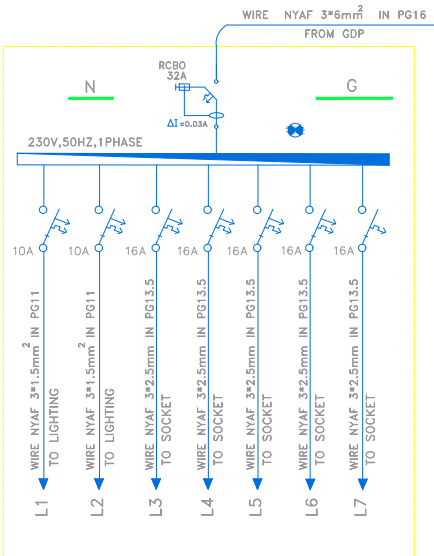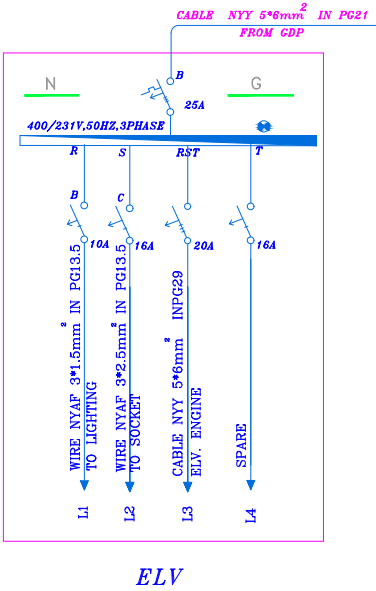


DPS

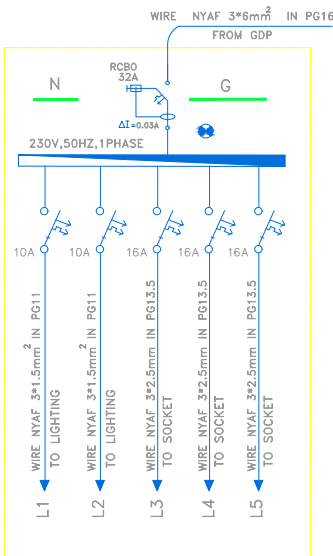

DPS1

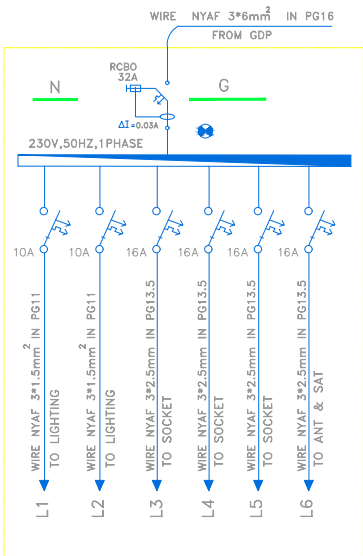

DPR

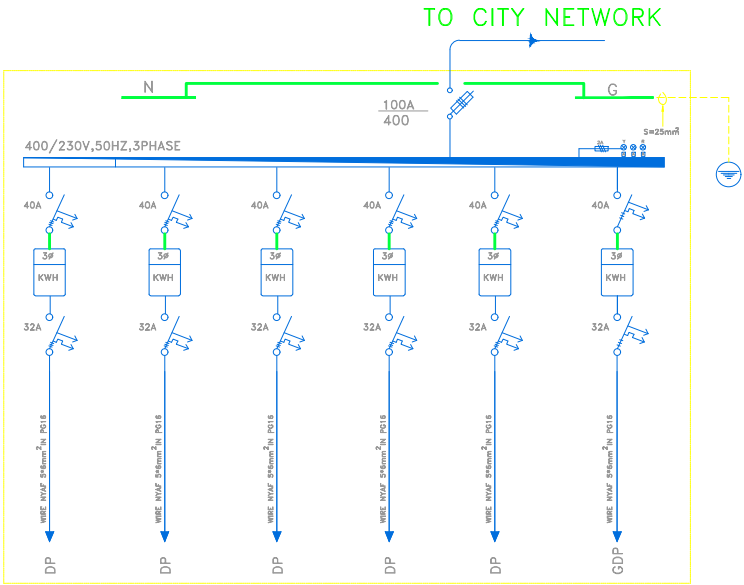

MDPB

DRAWING

ELECTRICAL AS BUILT

DRAWN BY:

HONAAM CO.

INSPECTED BY: BEHROUZ ARMANI

WEBSITE

WWW.HONAAM.COM

MAIL

mail@honaam.com

PROJECT

MAAH NAAZ 4 RESIDENCE

LOCATION:

JAHAN SHAHR, ALBORZ

NASTARAN ST NO 101

DESCRIPTION

REV	DATE	NOTES
01	2024/07/21	---

DRAWING

HONAAM CO.

CHECKED BY

BEHROUZ ARMANI

NO.
H-236


REV.
01

SCALE


1:100

PAGE


E- 504

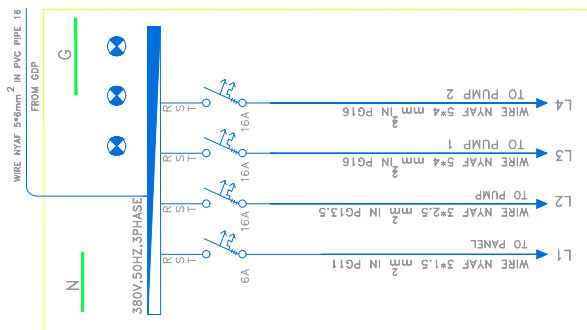

DPN2

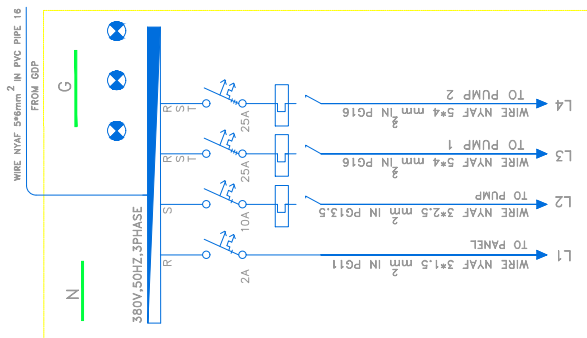

DPM1

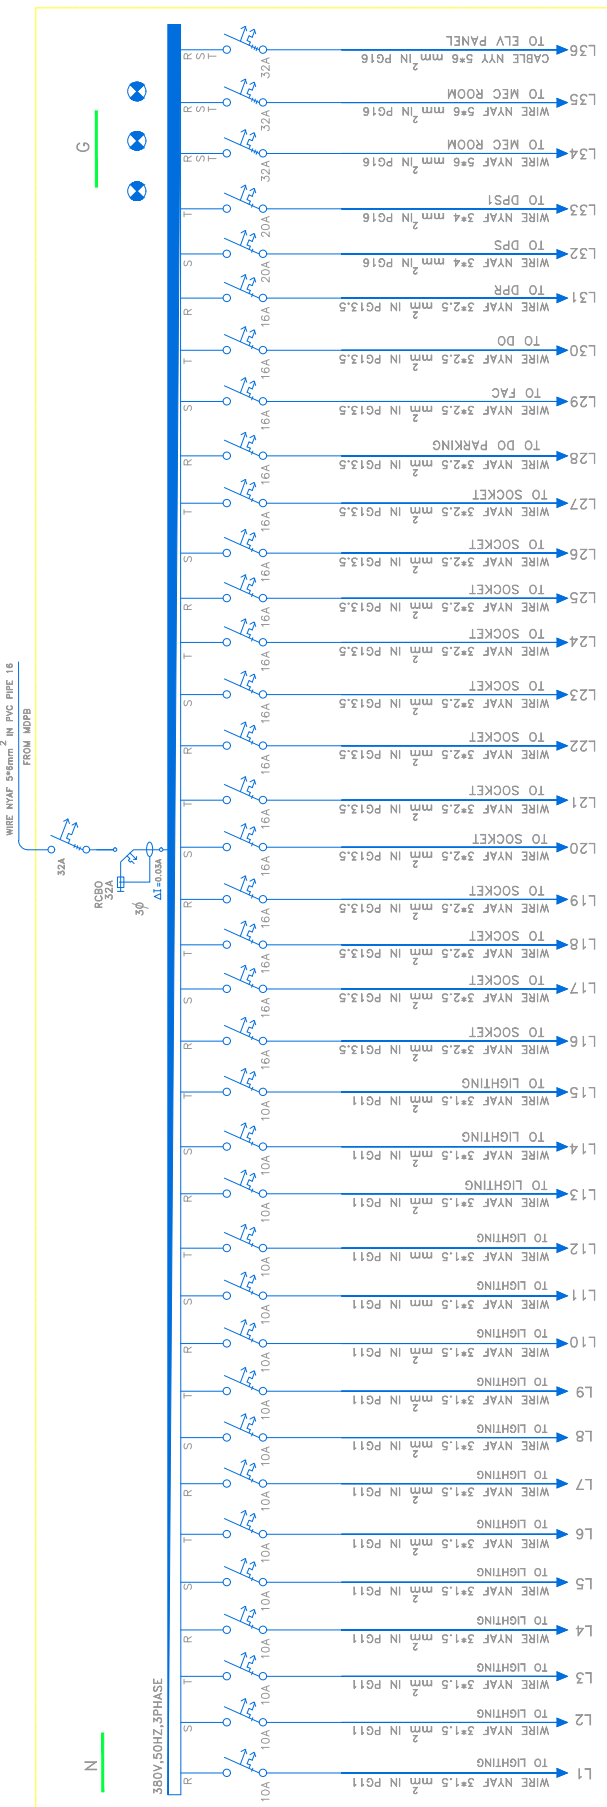

உ
ட
க

